


LOADING DOCKS

DRIVE-IN RAMP

One Water 2021

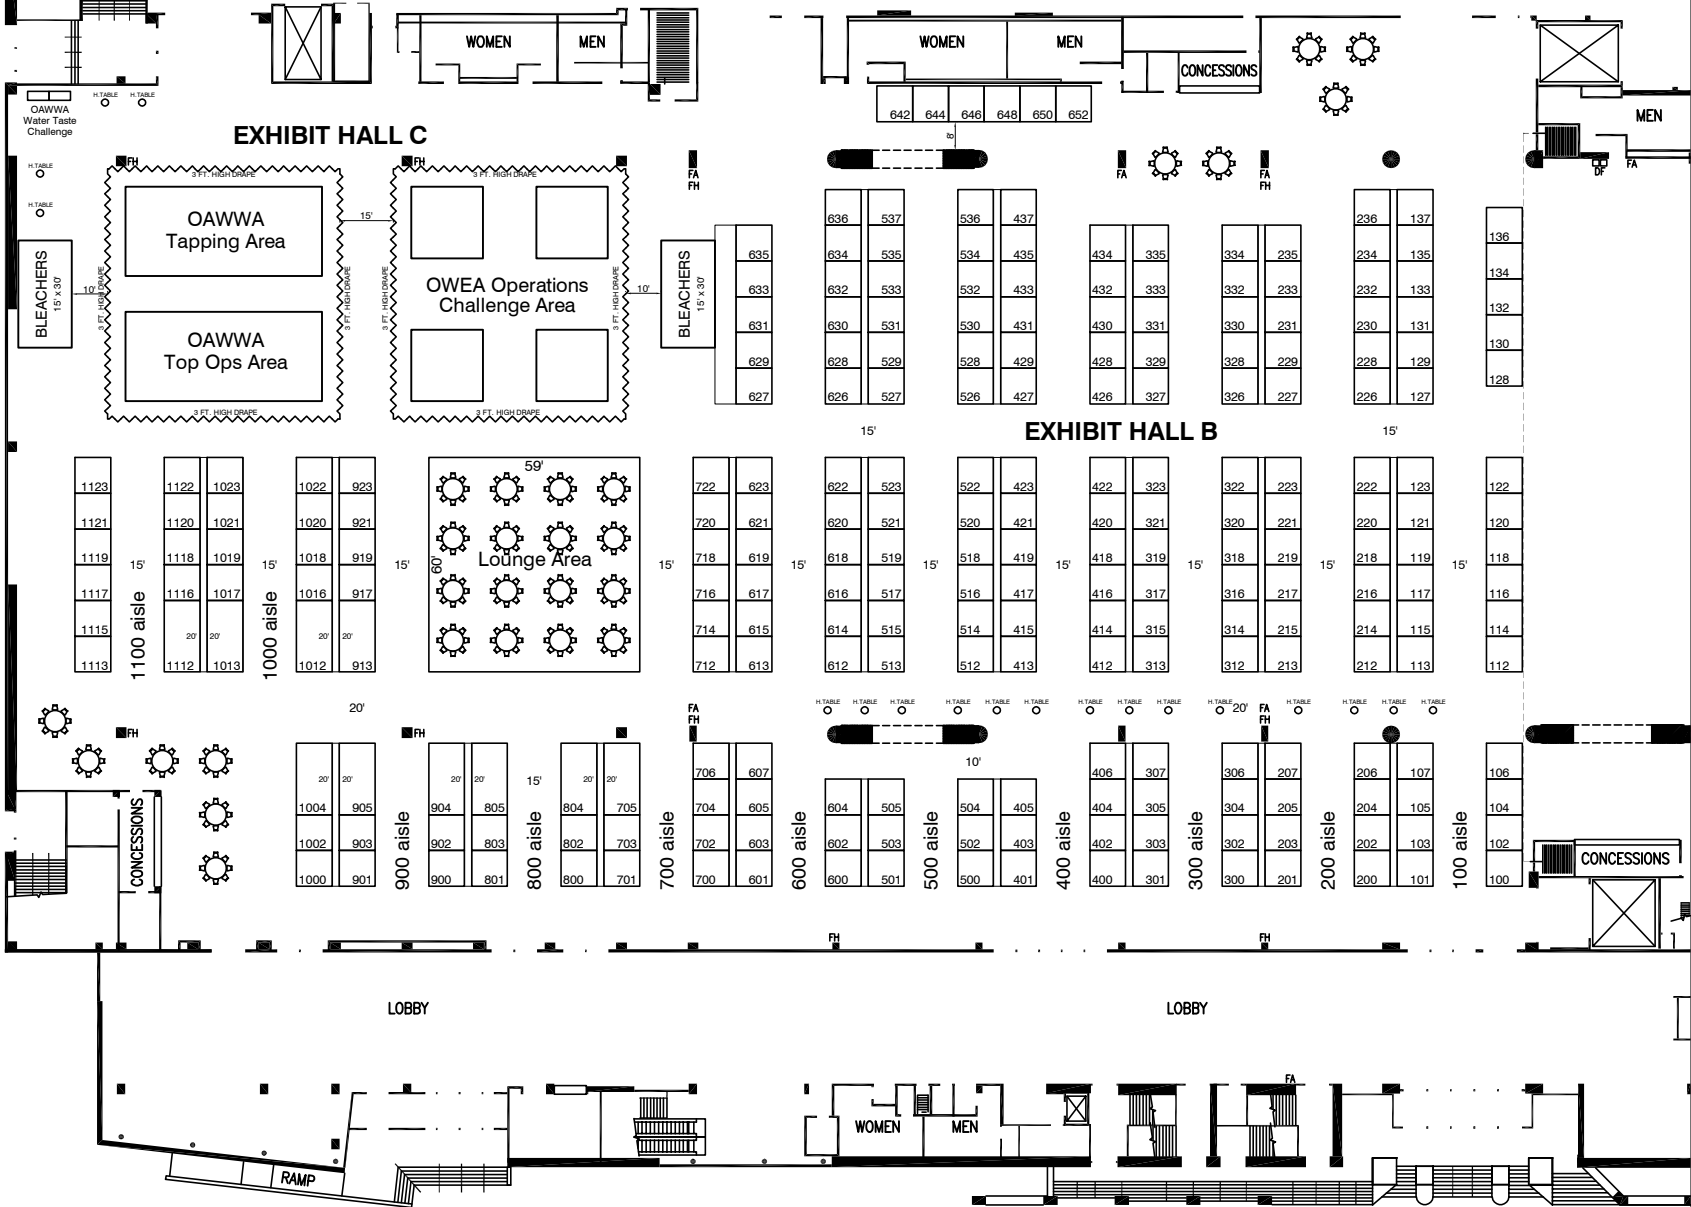

One Water 2021

July 26- 29, 2021

Duke Energy Convention Center

Cincinnati, OH

Exhibit Halls B & C

Legend:

Inventory as of 11/13/2020				
Dimension	Size	Qty	SqFt	
10x10'	100	232	23,200	
10x20'	200	10	2,000	
Totals:		242	25,200	

AE: Carolyn Hodge

Show Number: 11811

Drawn By: Gail Bamforth

Scale: 5/256" = 1'

 
Revised: 11/13/2020 11:35 AM

File: 11811-2-21 one_water_r2.dwg

Every effort has been made to ensure the accuracy of all information contained on this floor plan. However, no warranties, either expressed or implied are made with respect to this floor plan. If the location of building columns, utilities or other architectural components of the facility is a consideration in the construction of an exhibit, it is the sole responsibility of the exhibitor to physically inspect the facility to verify all dimensions and locations.

LEGEND

FE - FIRE EXTINGUISHER
 FA - FIRE ALARM LOCATION
 FH - FIRE HOSE LOCATION



DUKE ENERGY CONVENTION CENTER

CINCINNATI, OHIO

FIFTH STREET

